


City of El Cerrito
 SCCAP

ALBANY CHILDCARE CENTER
 900 BUCHANAN ST.
 ALBANY, CA 94706

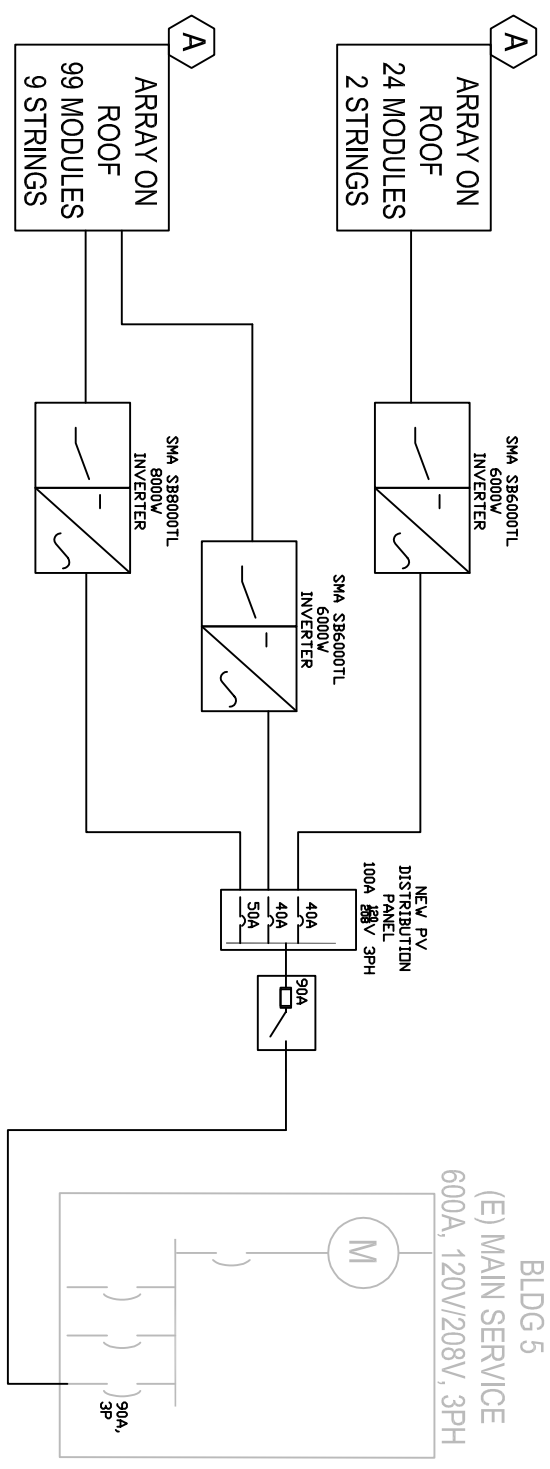

ALBANY CHILDCARE CENTER
 (84) TRINA 280 WATT MODULES IN
 (7) STRINGS OF 12 MODULES
 23.52 KW-DC

VERSION	DATE
PRELIMINARY DESIGN	10-19-2012

SHEET TITLE
 SINGLE LINE DIAGRAM
 DRAWN: SD CHECKED:

PV5.1